
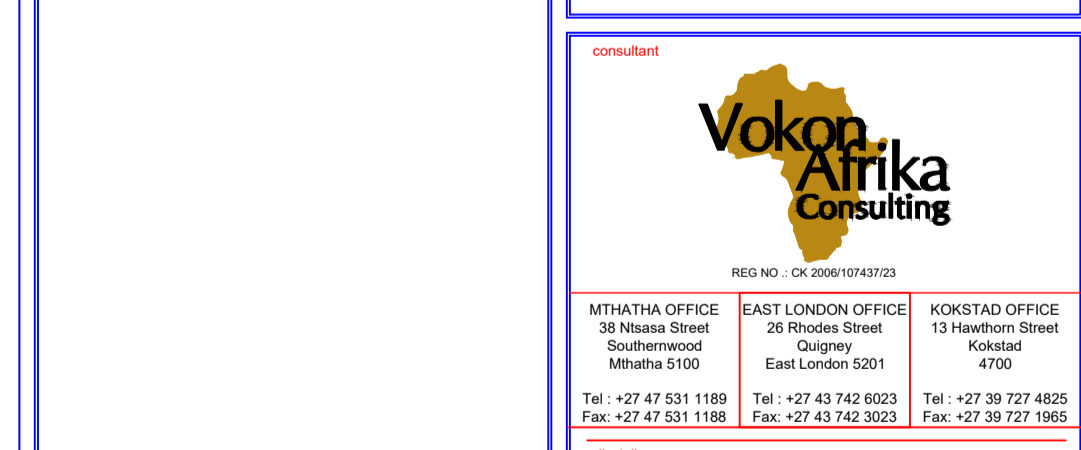


DRAWING NOTES	
NOTE: All works to comply with and carried out in strict accordance with national building regulations SABS 5400 - 1990. All dimensions to be checked on site before any work is put in hand. This drawing must not be scaled, only figured dimensions may be used.	
FAF / EAS	Inline Fresh / Exhaust Air Fan
EFICE	Exhaust Air Fan-Wall Mounted
GRILLE	Supply / Exhaust Air Grille
WL	Weather Louvre

NO.	AMENDMENT	ENG.


Copyright vests in the Department of Education
Preliminary drawings
Certified Preliminary drawings as per Controlled Drawing
Active Preliminary DRAWING REQUIREMENTS
name: _____
date: _____
professional registration no.: _____

used file name: _____ page type: _____
VENT Plans **A 1**

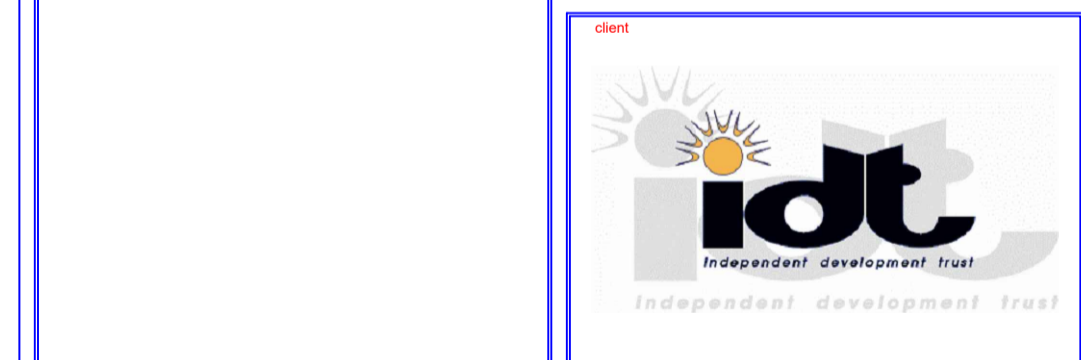


REG NO: CK-305010143703
 MTHATHA OFFICE: 38 Ribaza Street, Southernwood, Mthatha 5100
 EAST LONDON OFFICE: 26 Rhodes Street, Gugulethu, East London 5201
 KOKSTAD OFFICE: 13 Hawthorn Street, Kokstad 4700
 Tel: +27 47 531 1189 Fax: +27 47 531 1188
 Tel: +27 43 742 0023 Fax: +27 43 742 0023
 Tel: +27 39 727 4825 Fax: +27 39 727 1965
 discipline: **MECHANICAL ENGINEER**
 service: **SIVE / MALUTI SPECIAL SCHOOL PHASE-2**
 WCS number: _____
 drawing title: **ADMINISTRATION BUILDING HVAC LAYOUT**
 ref no: B assigned: Mr. M.C Mntshu
 scale: 1:50 drawn: Mr. L. Mngq
 date: April 2023 checked: Mr. N. Kekane
 drawing number: **ME-0031-HVAC-01**

DRAWING STATUS	
Description	Approved AS, BY
Issued For Concept Only	
Issued For Information Only	
Issued For Co-Ordination Only	
Issued For Preliminary Only	
Issued For Construction	
Issued For Final Construction	
AS Built Drawing	

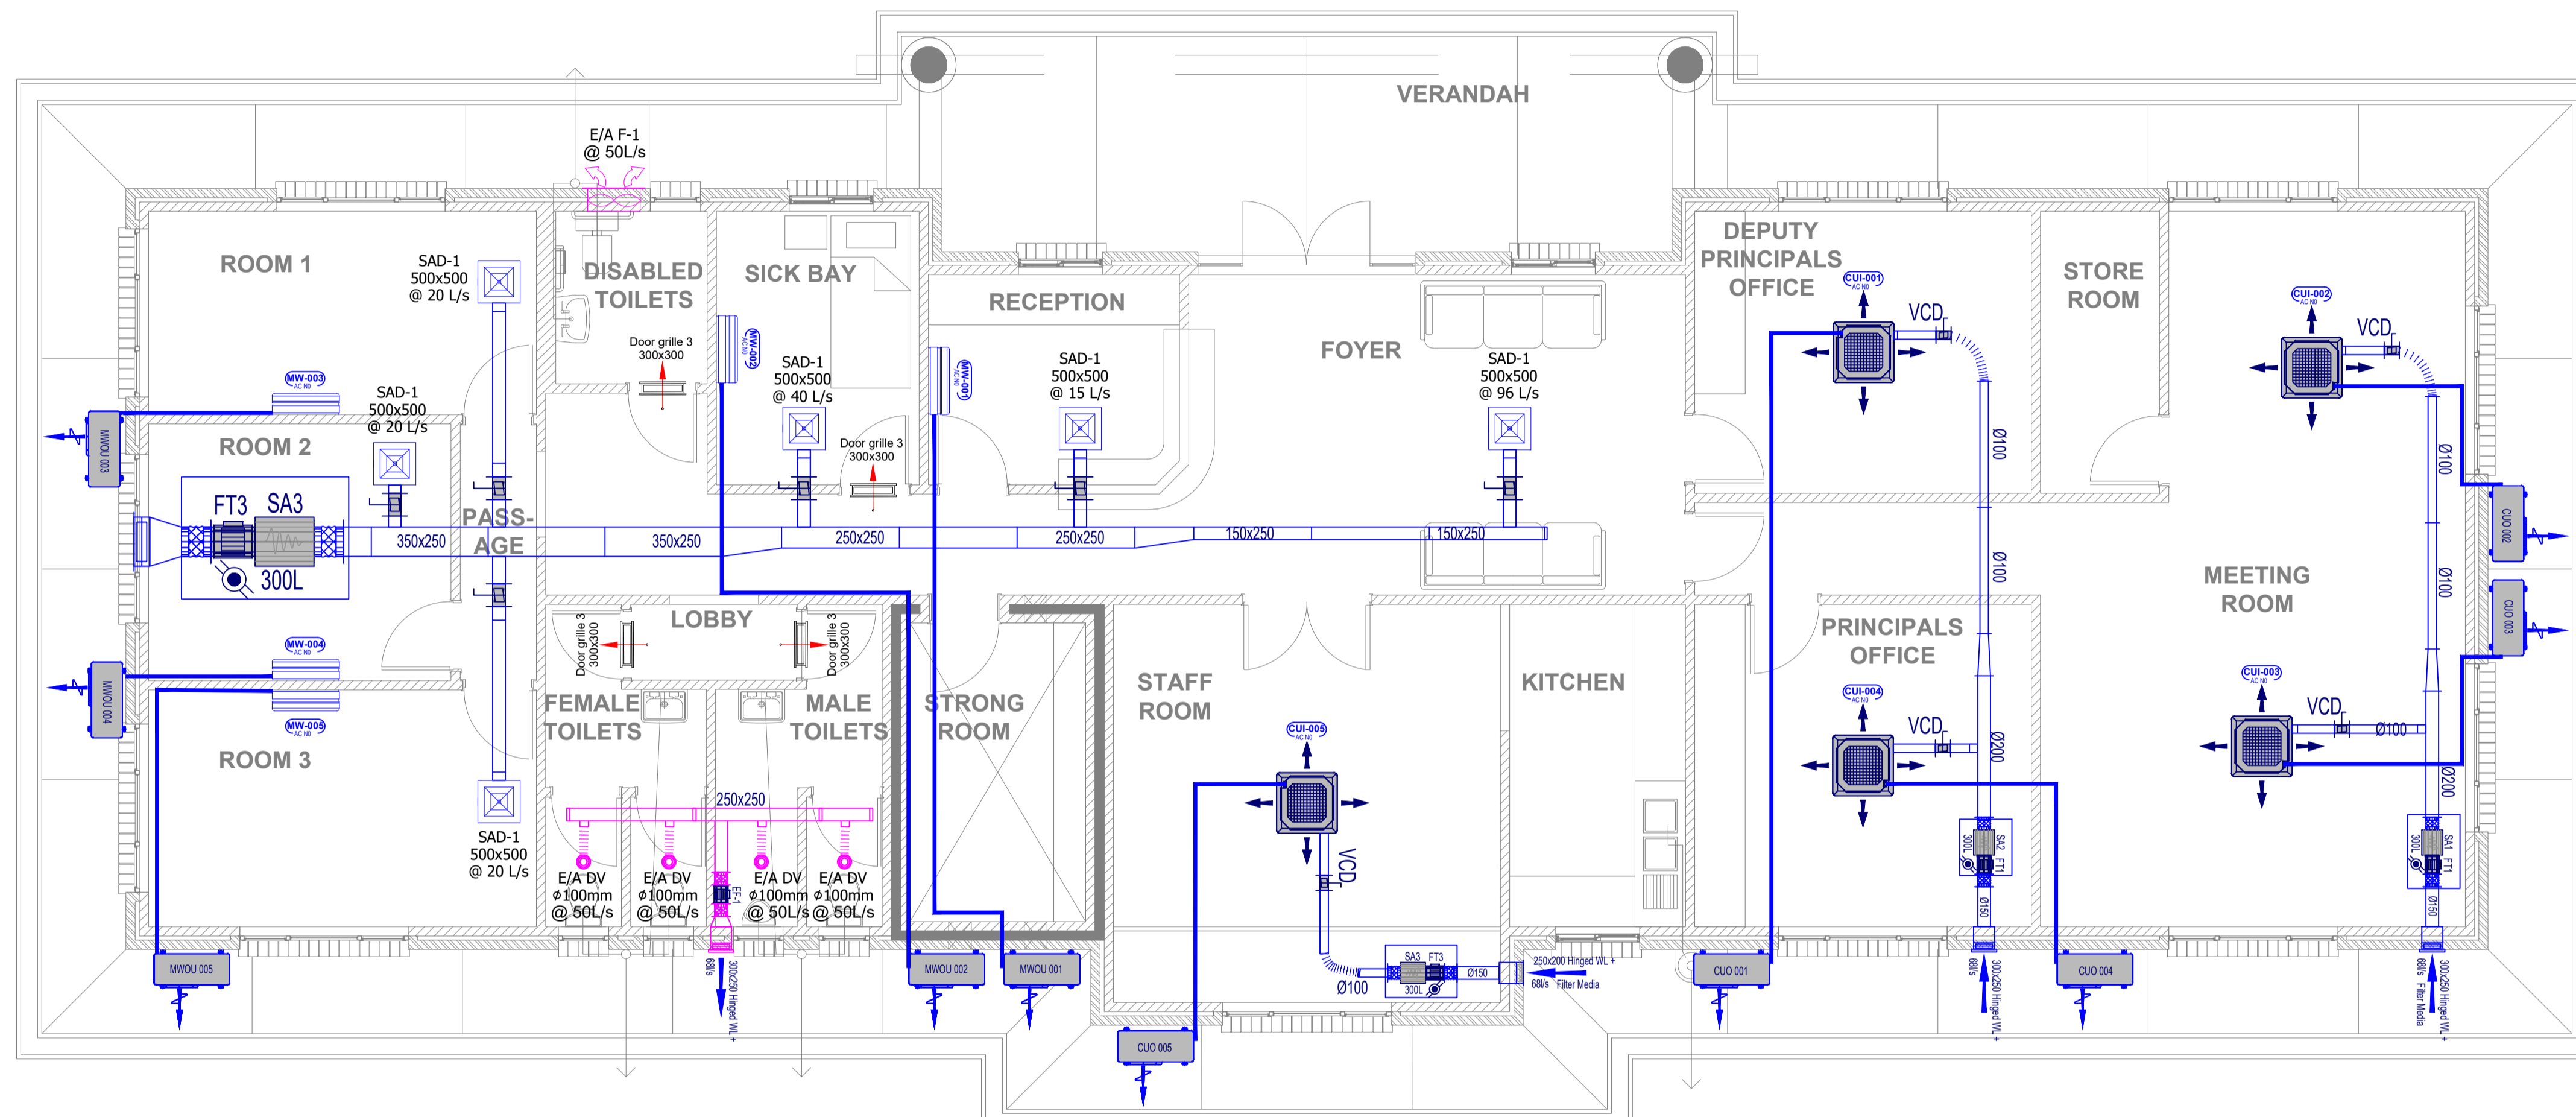

ADMINISTRATION BUILDING SCALE 1:50

SPLIT UNITS LEGEND						
ITEM	QTY	DESCRIPTION	SIZE	POWER REQUIREMENTS	Max KW	
AC1	1	Ceiling Cassette - H & C	5.27Kw	1PH,220/240V,9.0A Running, 38.0 Starting	9.2 kW	
AC2	1	Ceiling Cassette - H & C	2.64Kw	1PH,220/240V,4.0A Running, 18.5 Starting	4.5 kW	
AC3	1	Ceiling Cassette - H & C	2.64Kw	1PH,220/240V,4.0A Running, 18.5 Starting	4.5 kW	
AC4	1	Ceiling Cassette - H & C	5.27Kw	1PH,220/240V,9.0A Running, 38.0 Starting	9.2 kW	
AC5	1	Ceiling Cassette - H & C	2.05Kw	1PH,220/240V,4.0A Running, 18.5 Starting	4.5 kW	
AC6	1	Midwall Unit - Cooling Only	2.05Kw	1PH,220/240V,4.0A Running, 18.5 Starting	4.5 kW	
AC7	1	Midwall Unit - Cooling Only	2.05Kw	1PH,220/240V,4.0A Running, 18.5 Starting	4.5 kW	
AC8	1	Ceiling Cassette - H & C	5.27Kw	1PH,220/240V,7.0A Running, 38.0 Starting	9.2 kW	
AC9	1	Midwall Unit - Cooling Only	2.64Kw	1PH,220/240V,4.0A Running, 18.5 Starting	4.5 kW	

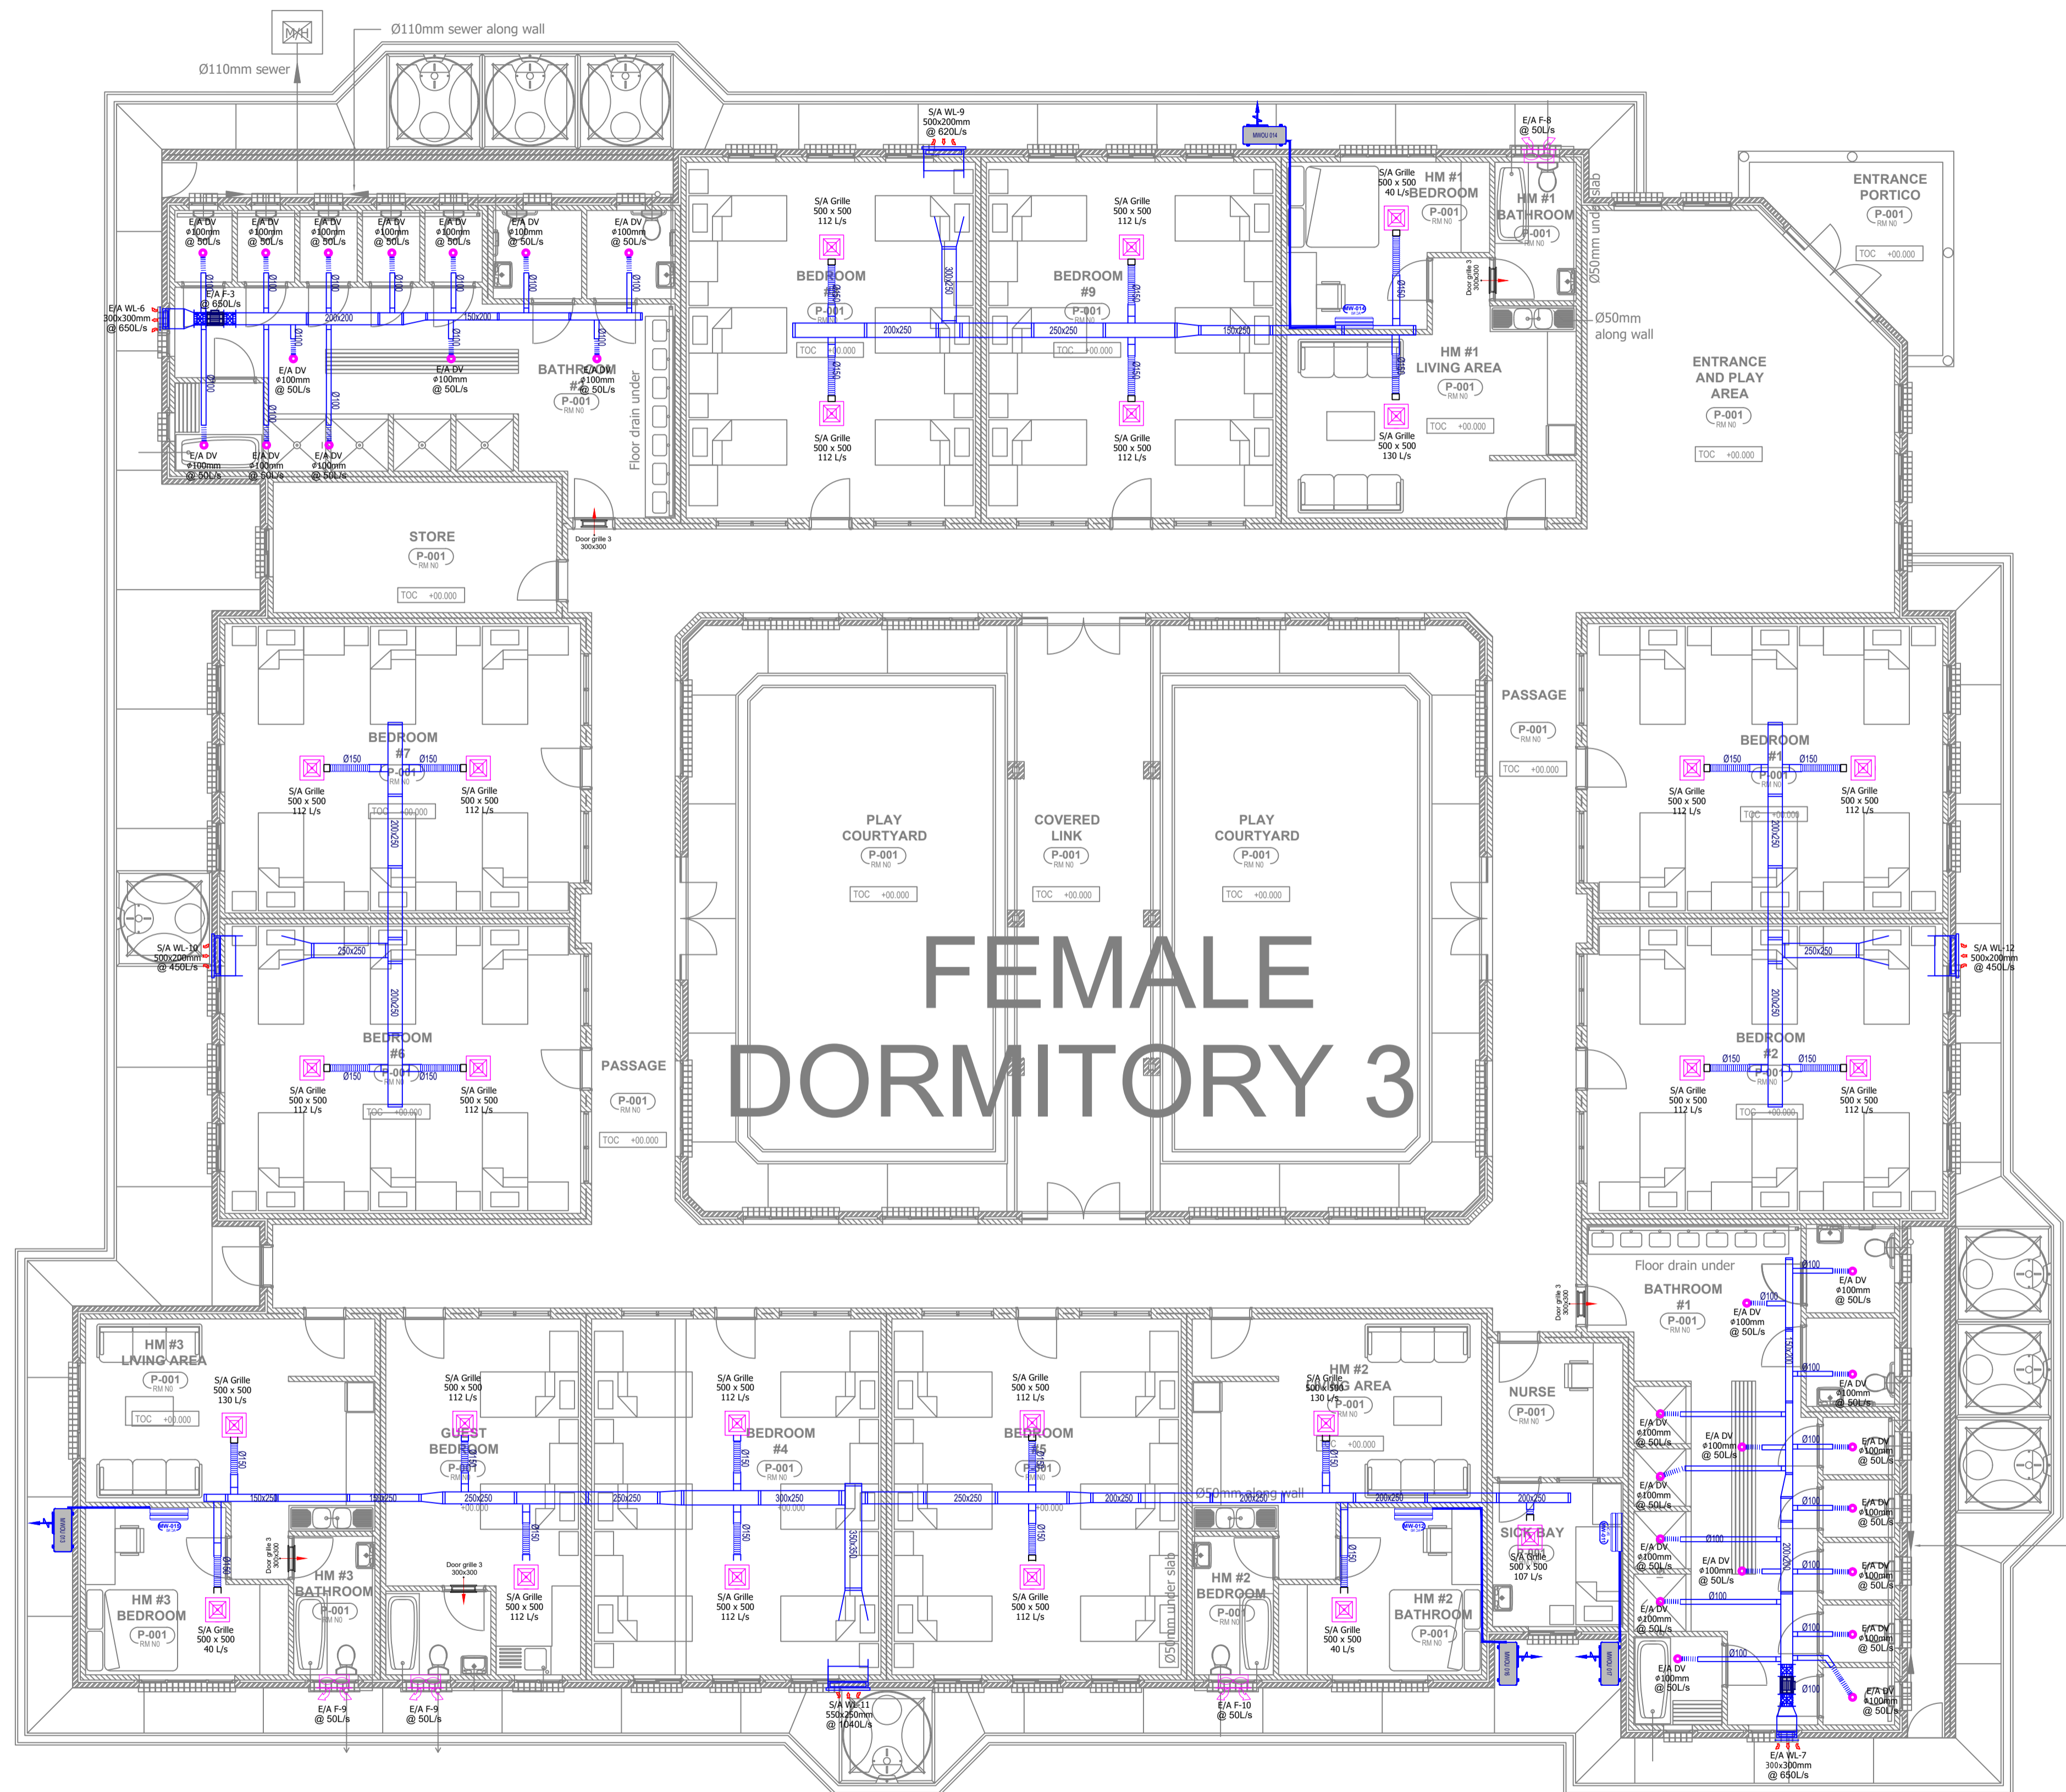


FEMALE DORMITORY 3

DRAWING NOTES	
NOTE: All works to comply with and carried out in strict accordance with national building regulations SABS 5400 - 1990. All dimensions to be checked on site before any work is put in hand. This drawing must not be scaled, only figured dimensions may be used.	
IAF / EAS	Inline Fresh / Exhaust Air Fan
EAFCE	Exhaust Air Fan-Wall Mounted
GRILLE	Supply / Exhaust Air Grille
WL	Weather Louvre

NO.	AMENDMENT	ENG.

Copyright vests in the Department of Education
 Preliminary drawings
 Certified Preliminary drawings as per Controlled Drawing
 Active Preliminary DRAWING REQUIREMENTS
 name: _____
 date: _____
 professional registration no.: _____

used file name: _____ page type: **A 1**
VENT Plans

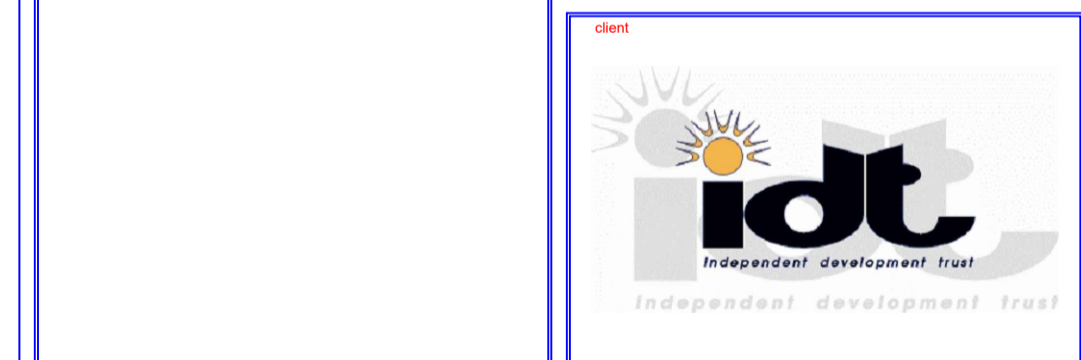

consultant
Vokon Afrika Consulting
 REG. NO.: CK-300610143703
 MATHATHA OFFICE: 38 Mthatha Street, Southernwood, Mthatha 5100
 EAST LONDON OFFICE: 26 Rhodes Street, Dugny, East London 5201
 KOKSTAD OFFICE: 13 Hawthorn Street, Kokstad 4700
 Tel: +27 47 531 1189 Fax: +27 47 531 1186
 Tel: +27 43 742 0023 Fax: +27 43 742 0023
 Tel: +27 39 727 4825 Fax: +27 39 727 1965

discipline: **MECHANICAL ENGINEER**
 service: _____


SIVE / MALUTI SPECIAL SCHOOL PHASE-2


DRAWING STATUS	
Description:	Approved AS, BY:
Issued For Concept Only	
Issued For Information Only	
Issued For Co-Ordination Only	
Issued For Preliminary Only	
Issued For Construction	
Issued For Final Construction	
AS Built Drawing	

drawing title: **FEMALE DORMITORY- 3 HVAC LAYOUT**

ref no: B	designed: Mr. M.C Mntu
scale: N.T.C	drawn: Mr. L. Maja
date: April 2023	checked: Mr. N. Kekane

 drawing number: **ME-0031-HVAC-02**



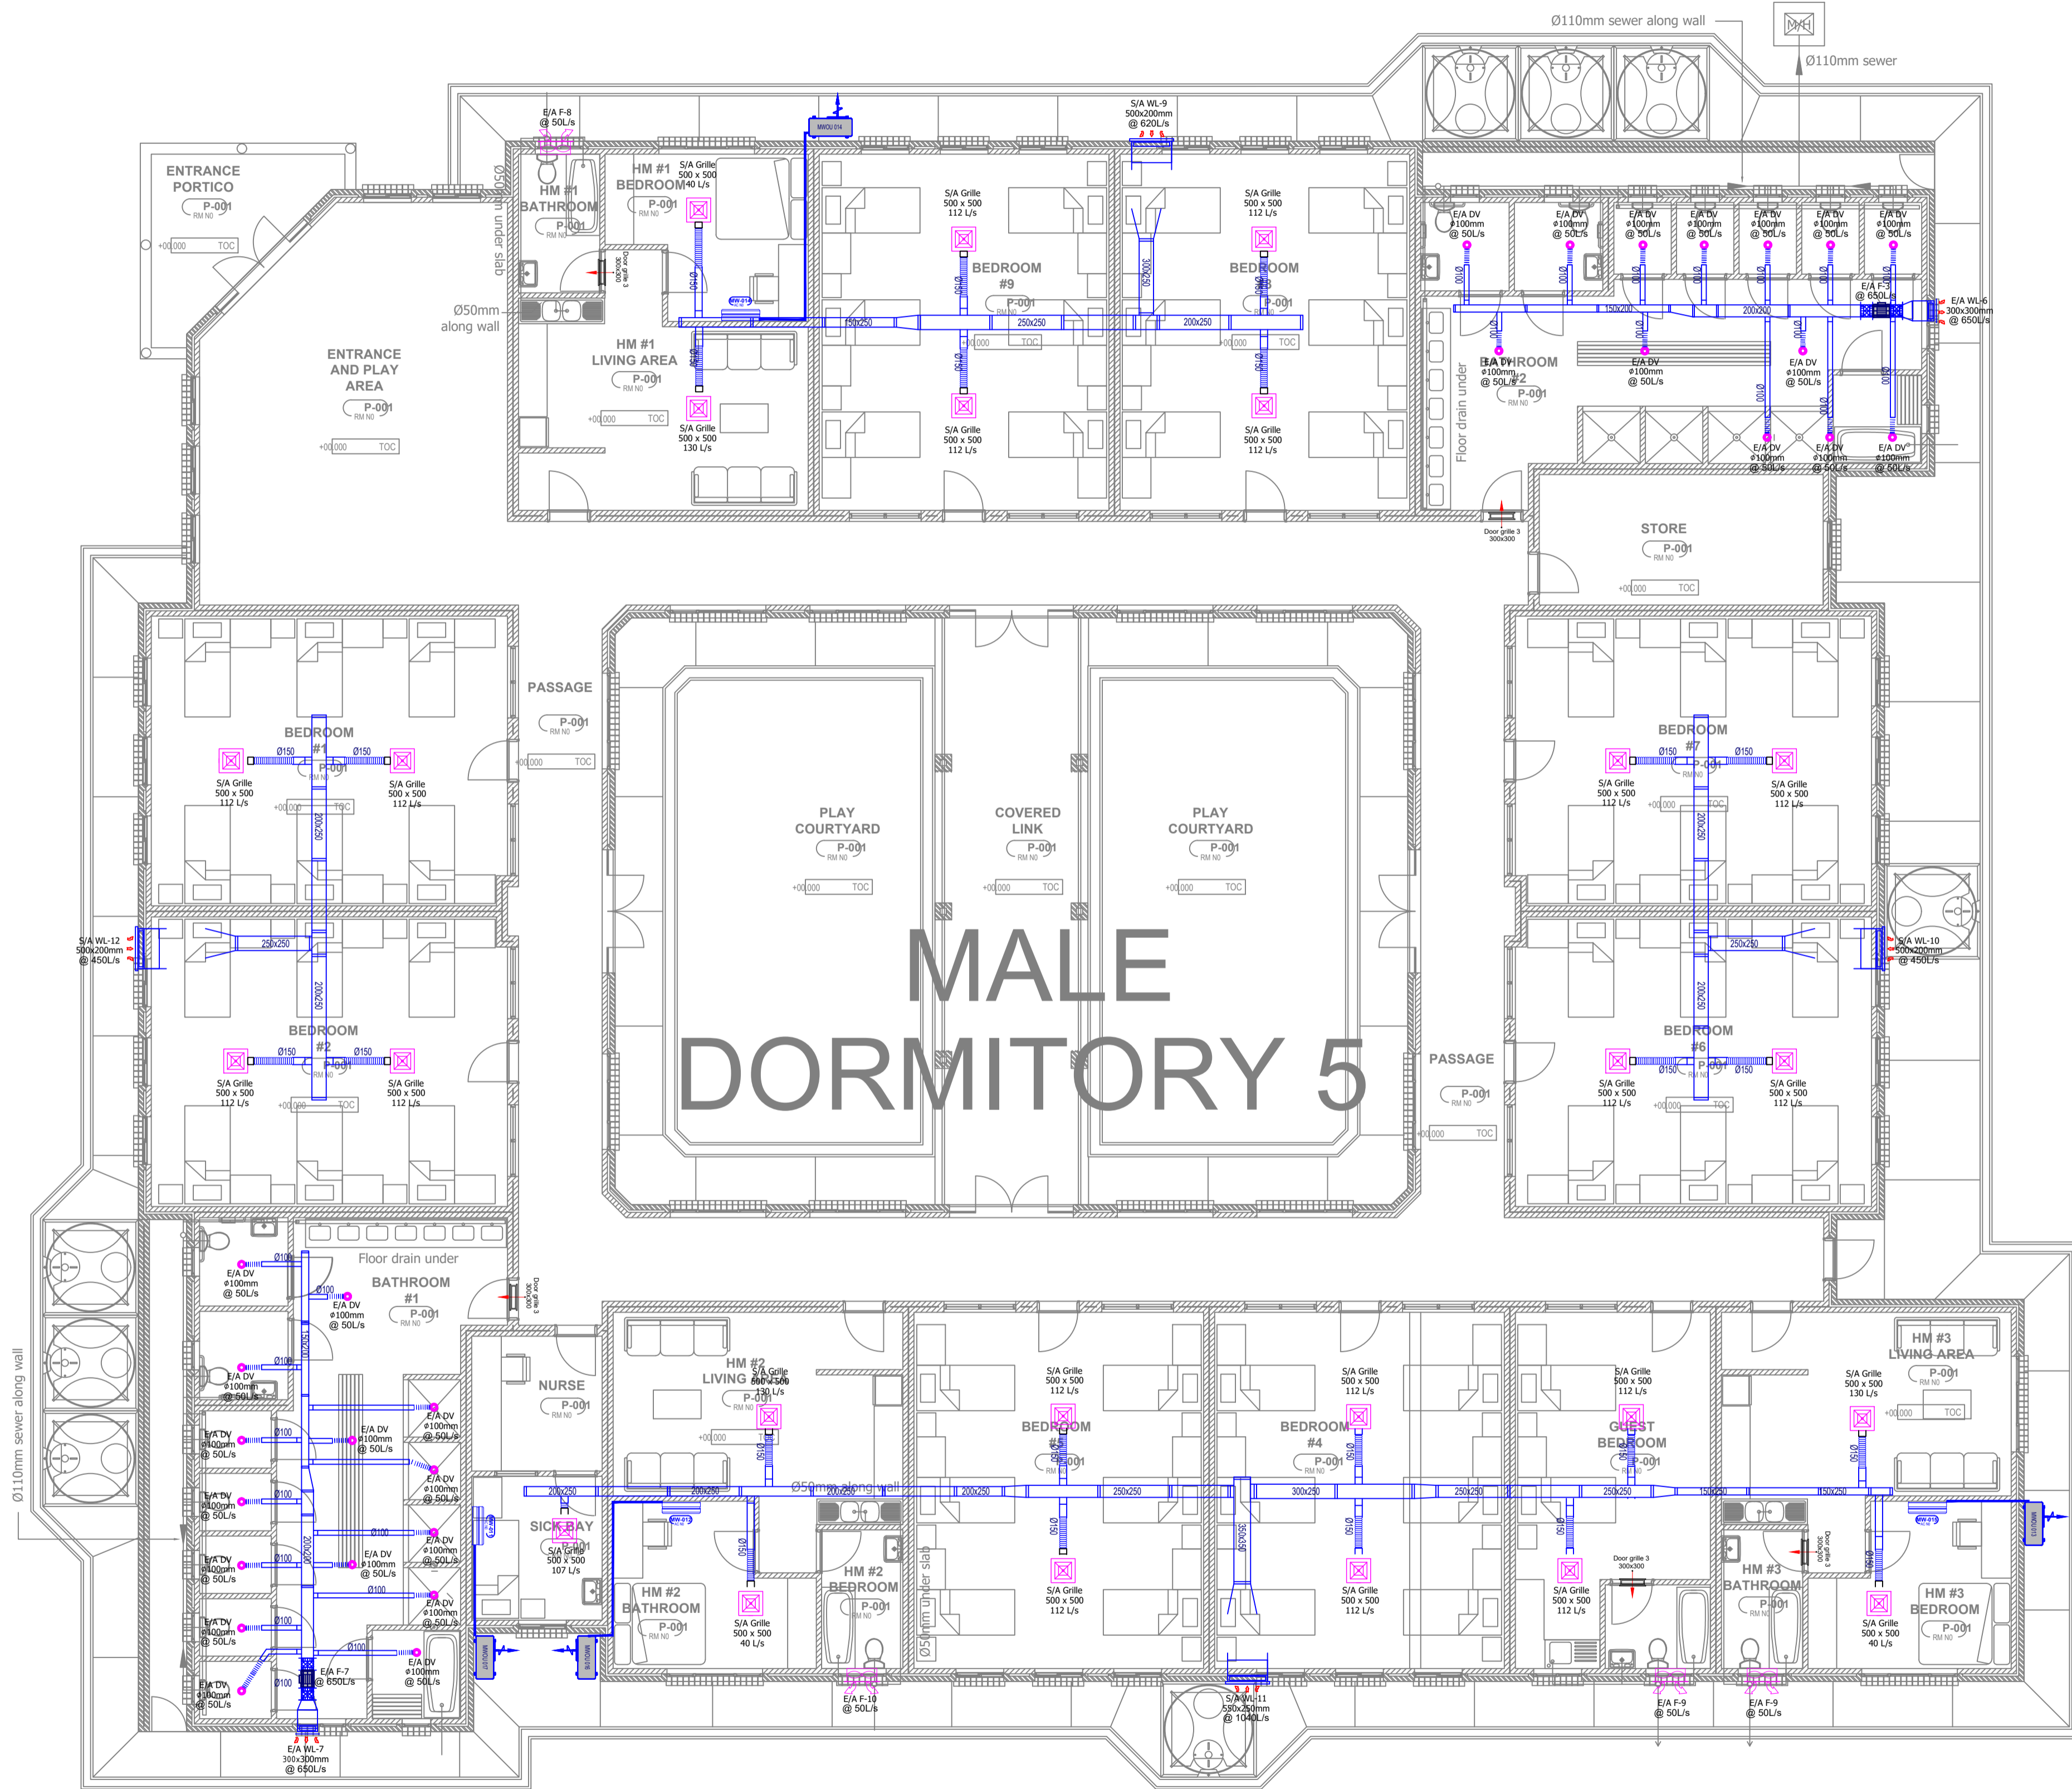


MALE DORMITORY 5

DRAWING NOTES	
NOTE: All works to comply with and carried out in strict accordance with national building regulations SABS 5400 - 1990. All dimensions to be checked on site before any work is put in hand. This drawing must not be scaled, only figured dimensions may be used.	
FAF / EAS	Inline Fresh / Exhaust Air Fan
EFICE	Exhaust Air Fan-Wall Mounted
GRILLE	Supply / Exhaust Air Grille
WL	Weather Louvre

NO.	AMENDMENT	ENG.

Copyright vests in the Department of Education
 Preliminary drawings
 Issued Preliminary drawings as per Controlled Drawing
 Active Preliminary DRAWING REQUIREMENTS
 name: _____
 date: _____
 professional registration no.: _____


used file name: _____ page type: **A 1**
VENT Plans



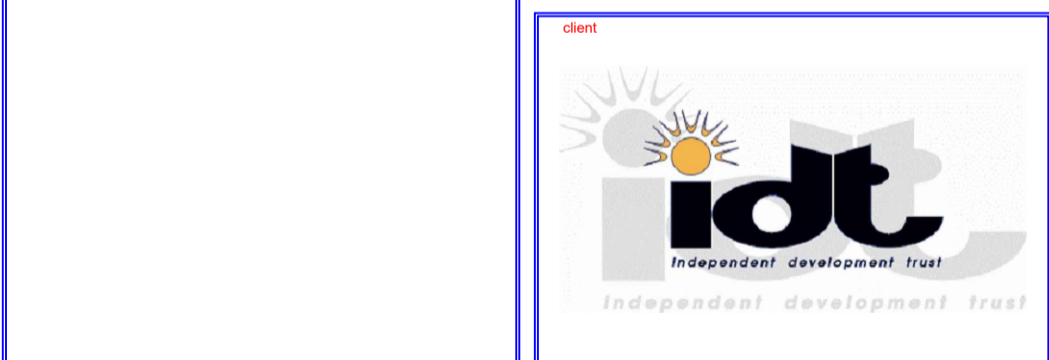


consultant
Vokon Afrika Consulting
 REG. NO.: CK-300810143703
 MITHATHA OFFICE: 38 Mithatha Street, Mithatha 5100
 EAST LONDON OFFICE: 26 Rhodes Street, East London 5201
 KOKSTAD OFFICE: 13 Hawthorn Street, Kokstad 4700
 Tel: +27 47 531 1189 Fax: +27 47 531 1198
 Tel: +27 47 742 0023 Fax: +27 47 742 0023
 Tel: +27 39 727 4825 Fax: +27 39 727 1965
 discipline: **MECHANICAL ENGINEER**
 service: **SIVE / MALUTI SPECIAL SCHOOL PHASE-2**

DRAWING STATUS	
Description	Approved AS, BY
Issued For Concept Only	
Issued For Information Only	
Issued For Co-Ordination Only	
Issued For Preliminary Only	
Issued For Construction	
Issued For Final Construction	
AS Built Drawing	

 drawing title: **MALE DORMITORY - 5 HVAC LAYOUT**
 ref no: B assigned: Mr. M.C Mntu
 scale: N.T.C. drawn: Mr. L. Maja
 date: April 2023 checked: Mr. N. Kekane
 drawing number: **ME-0031-HVAC-03**



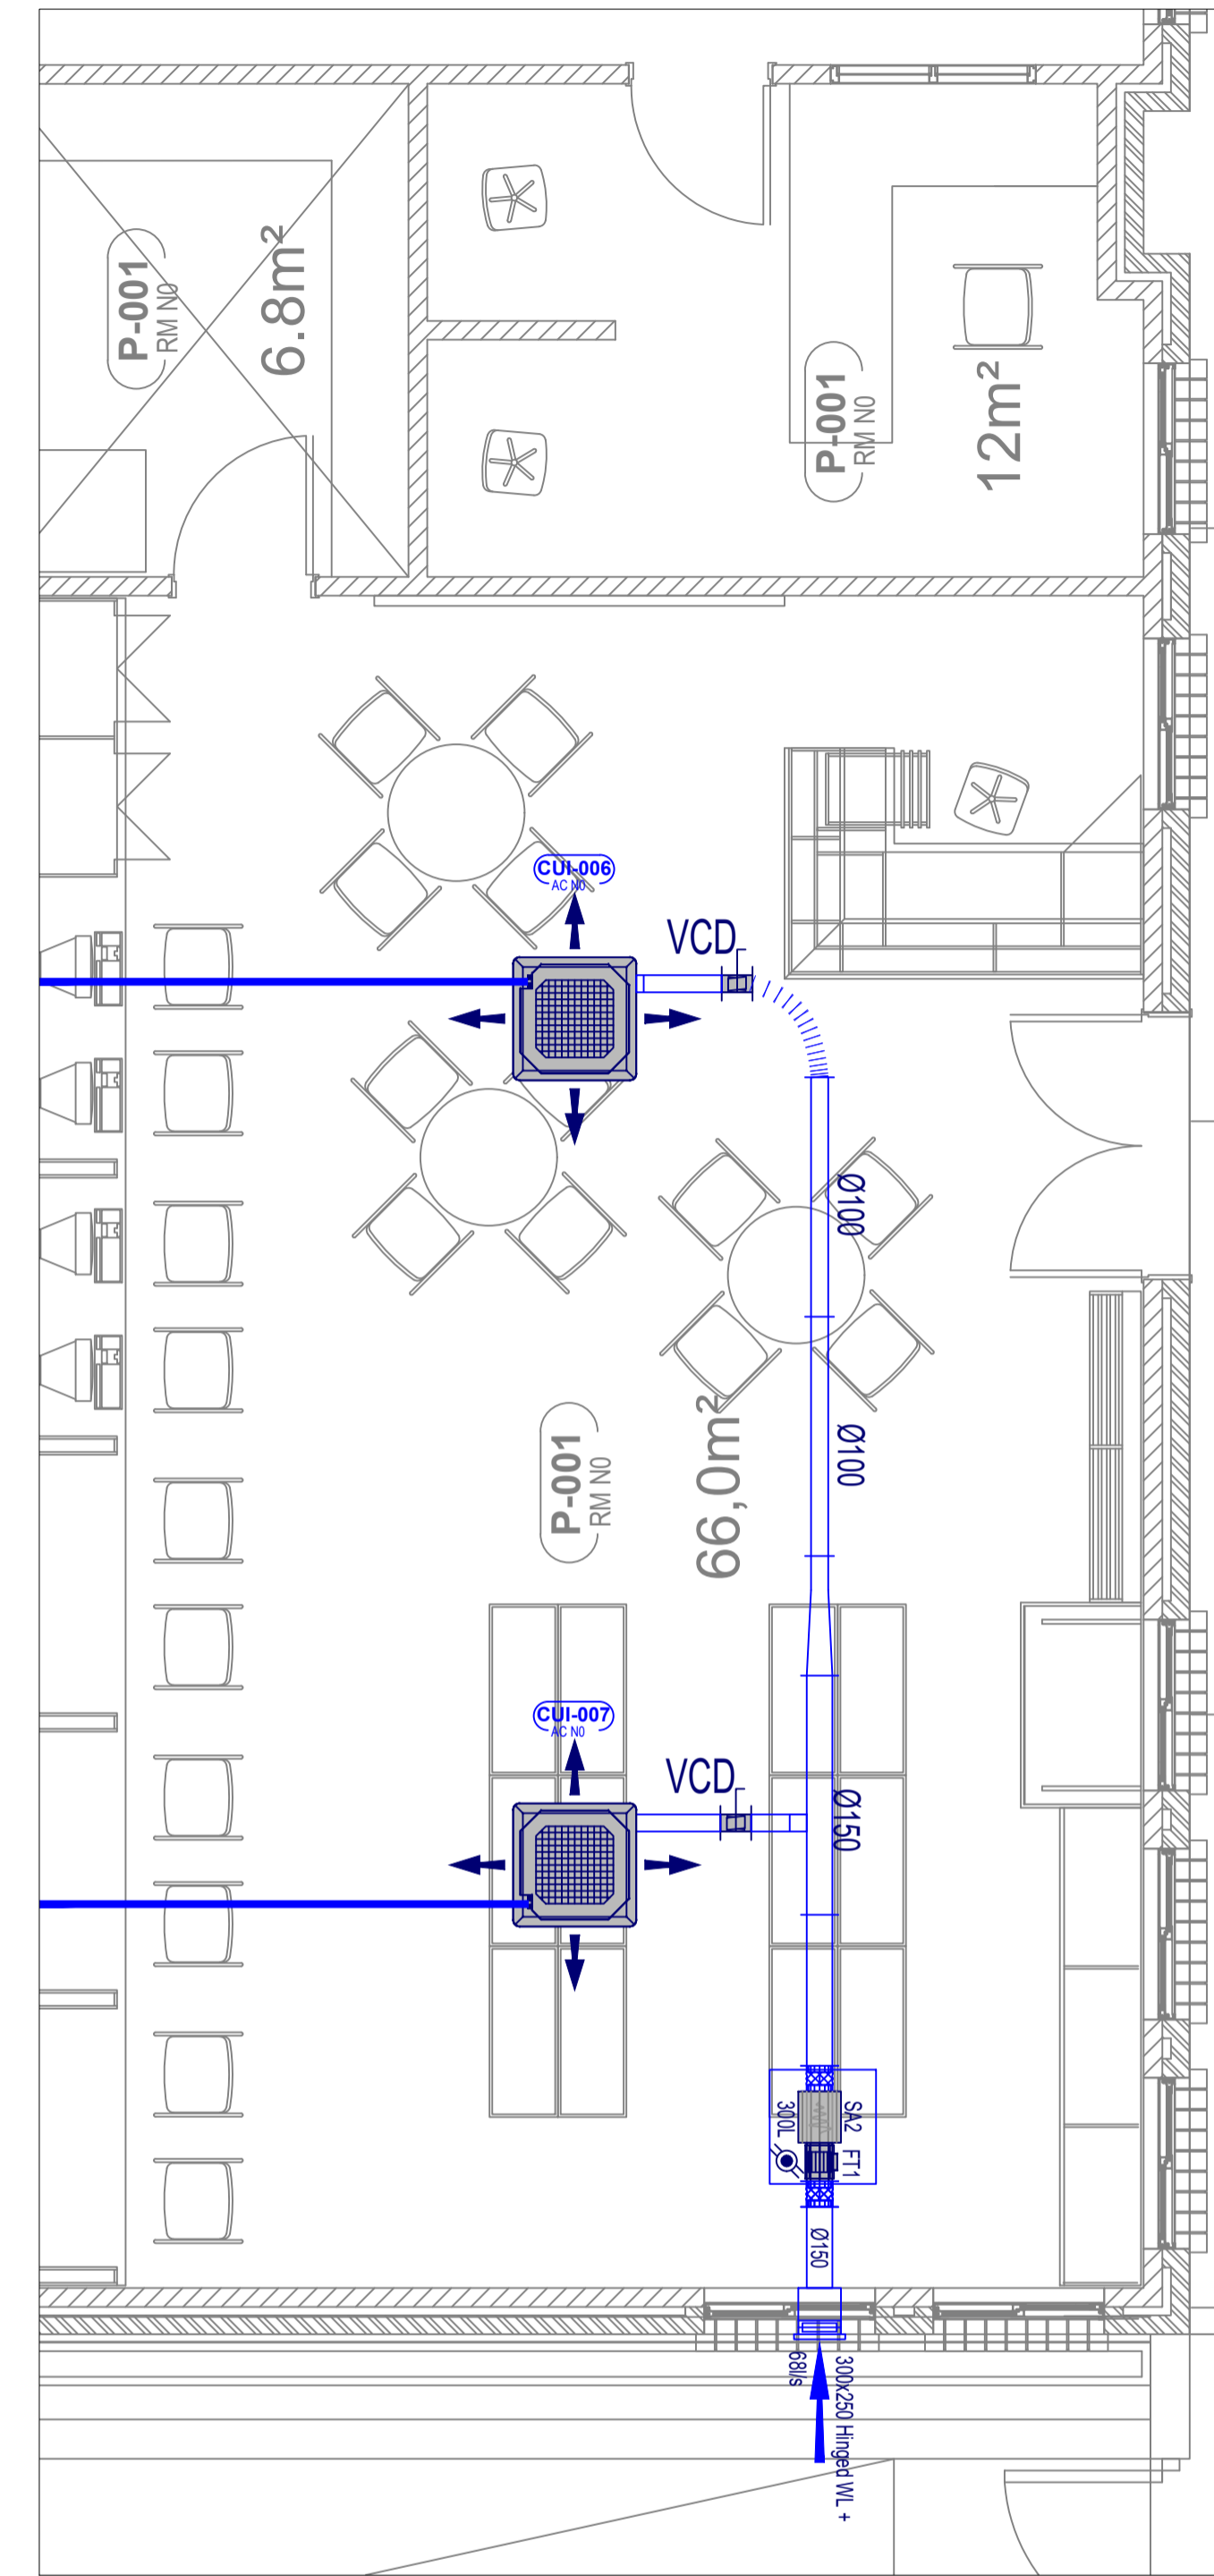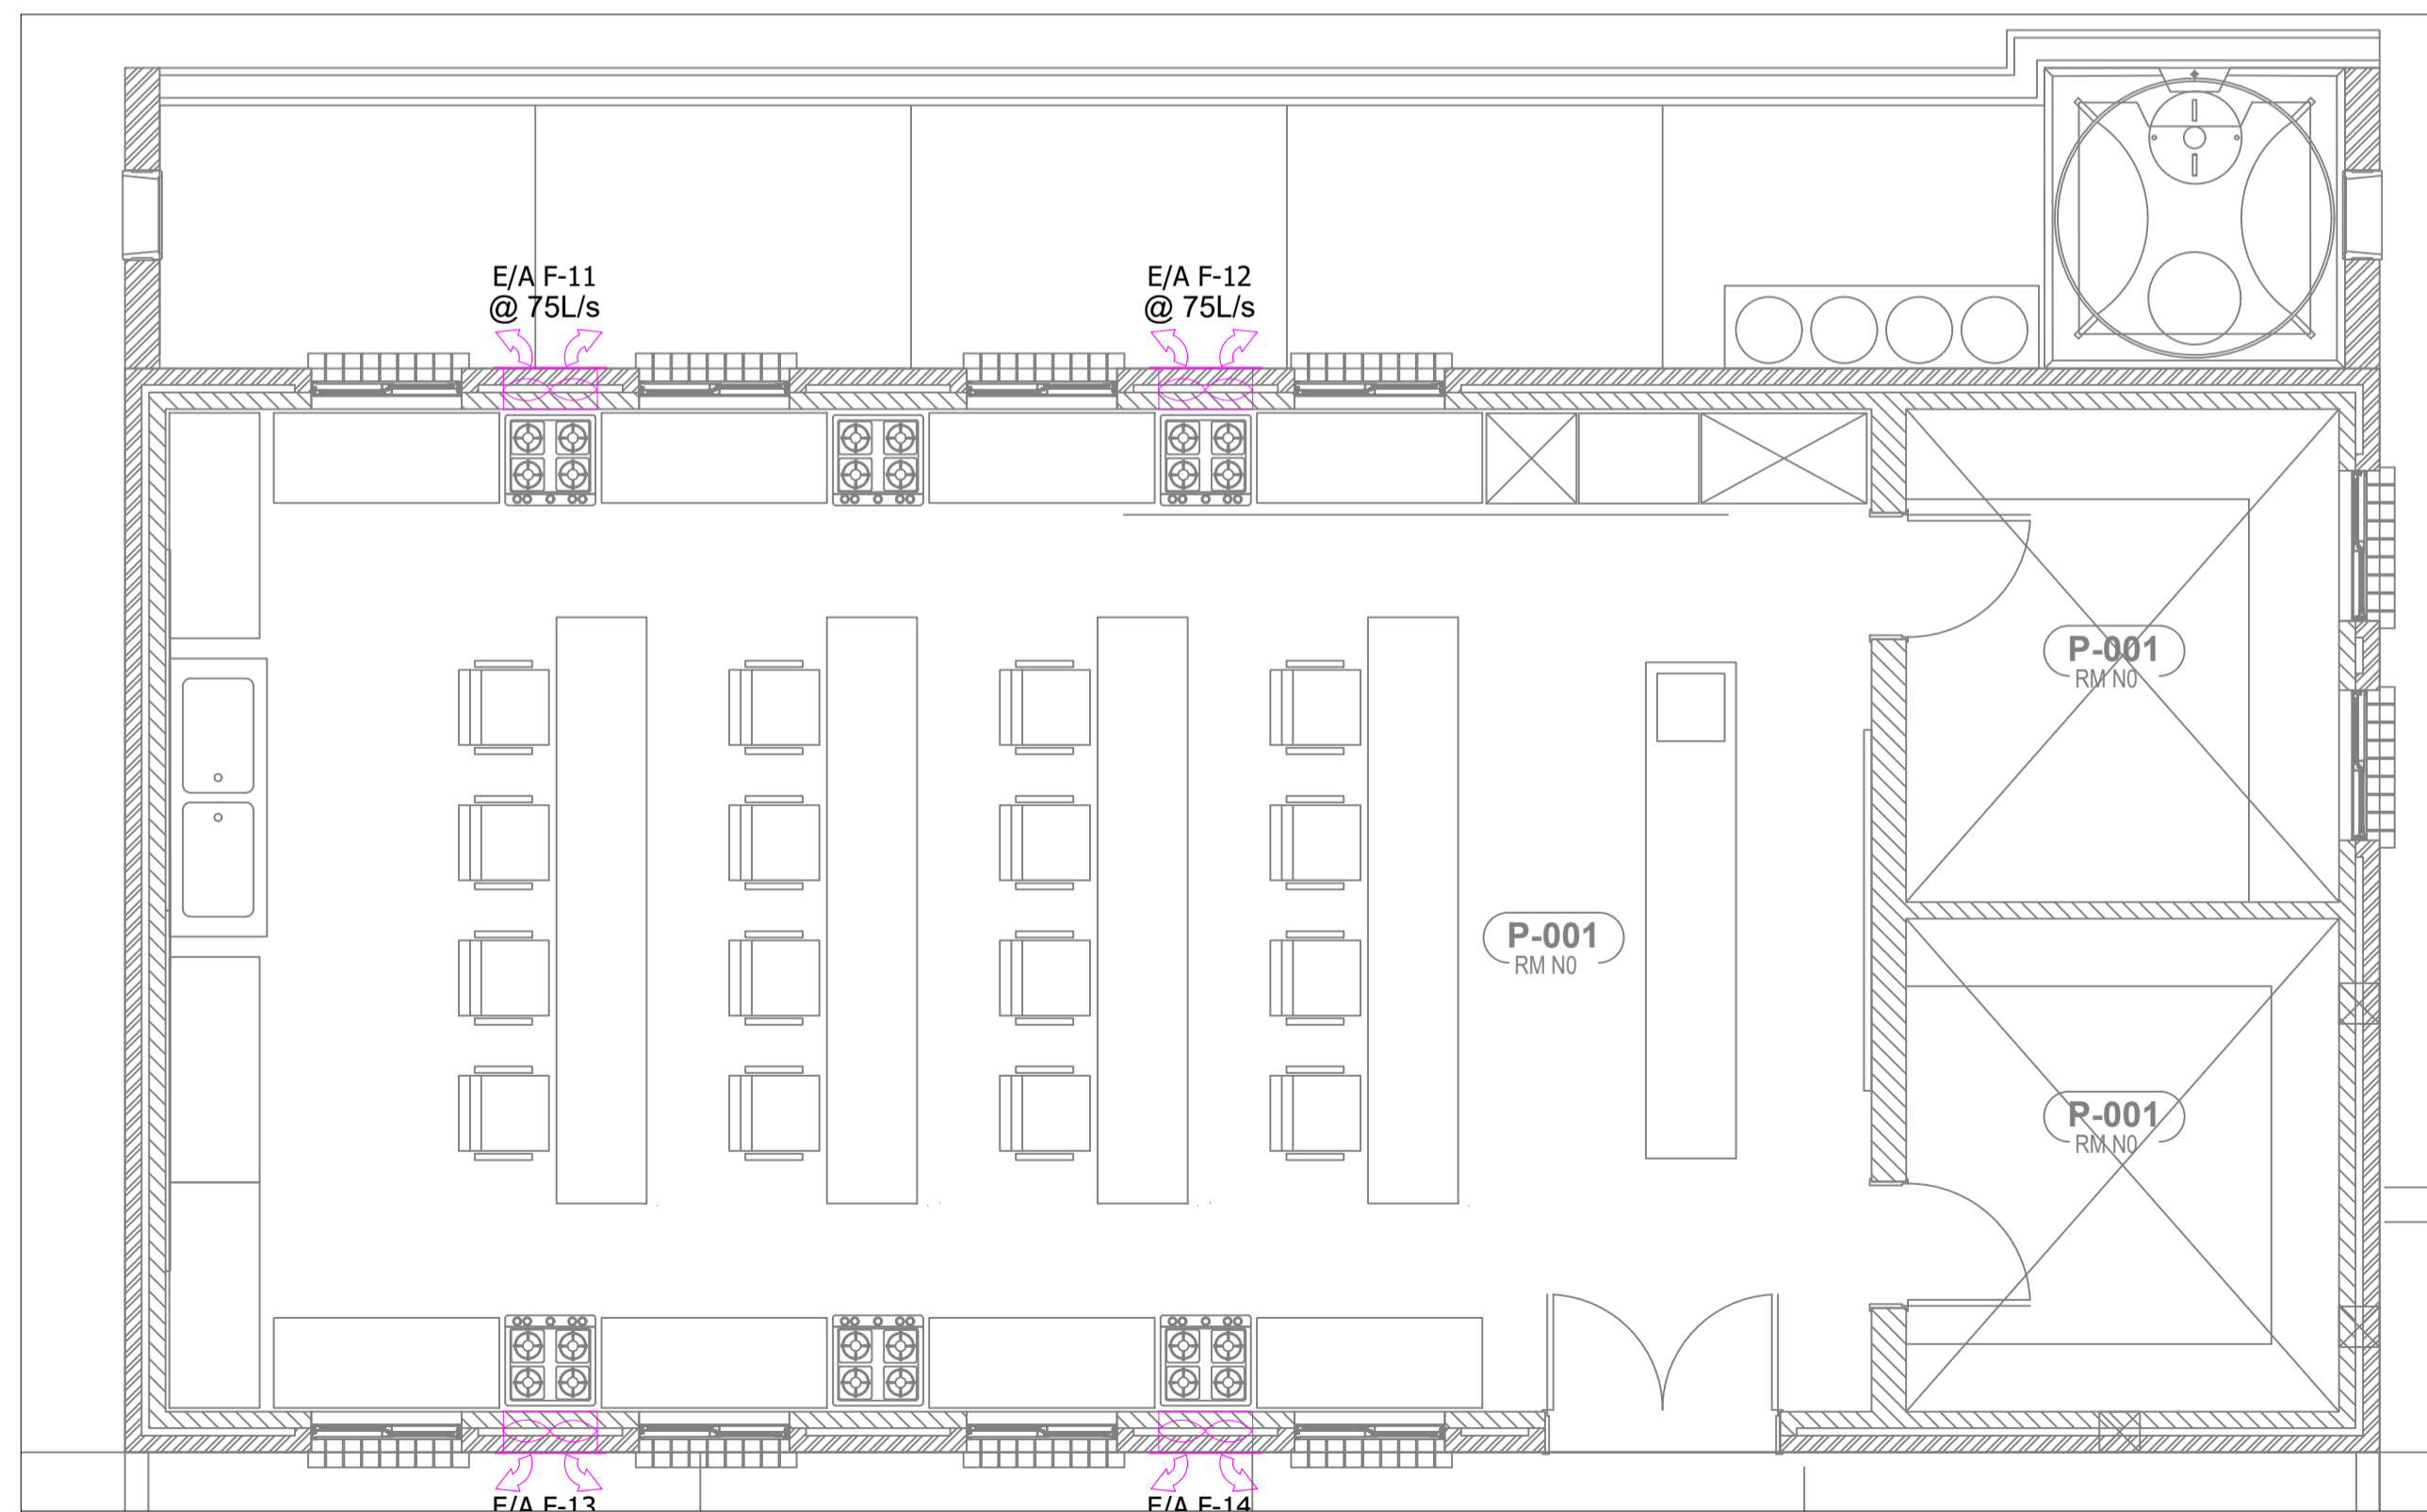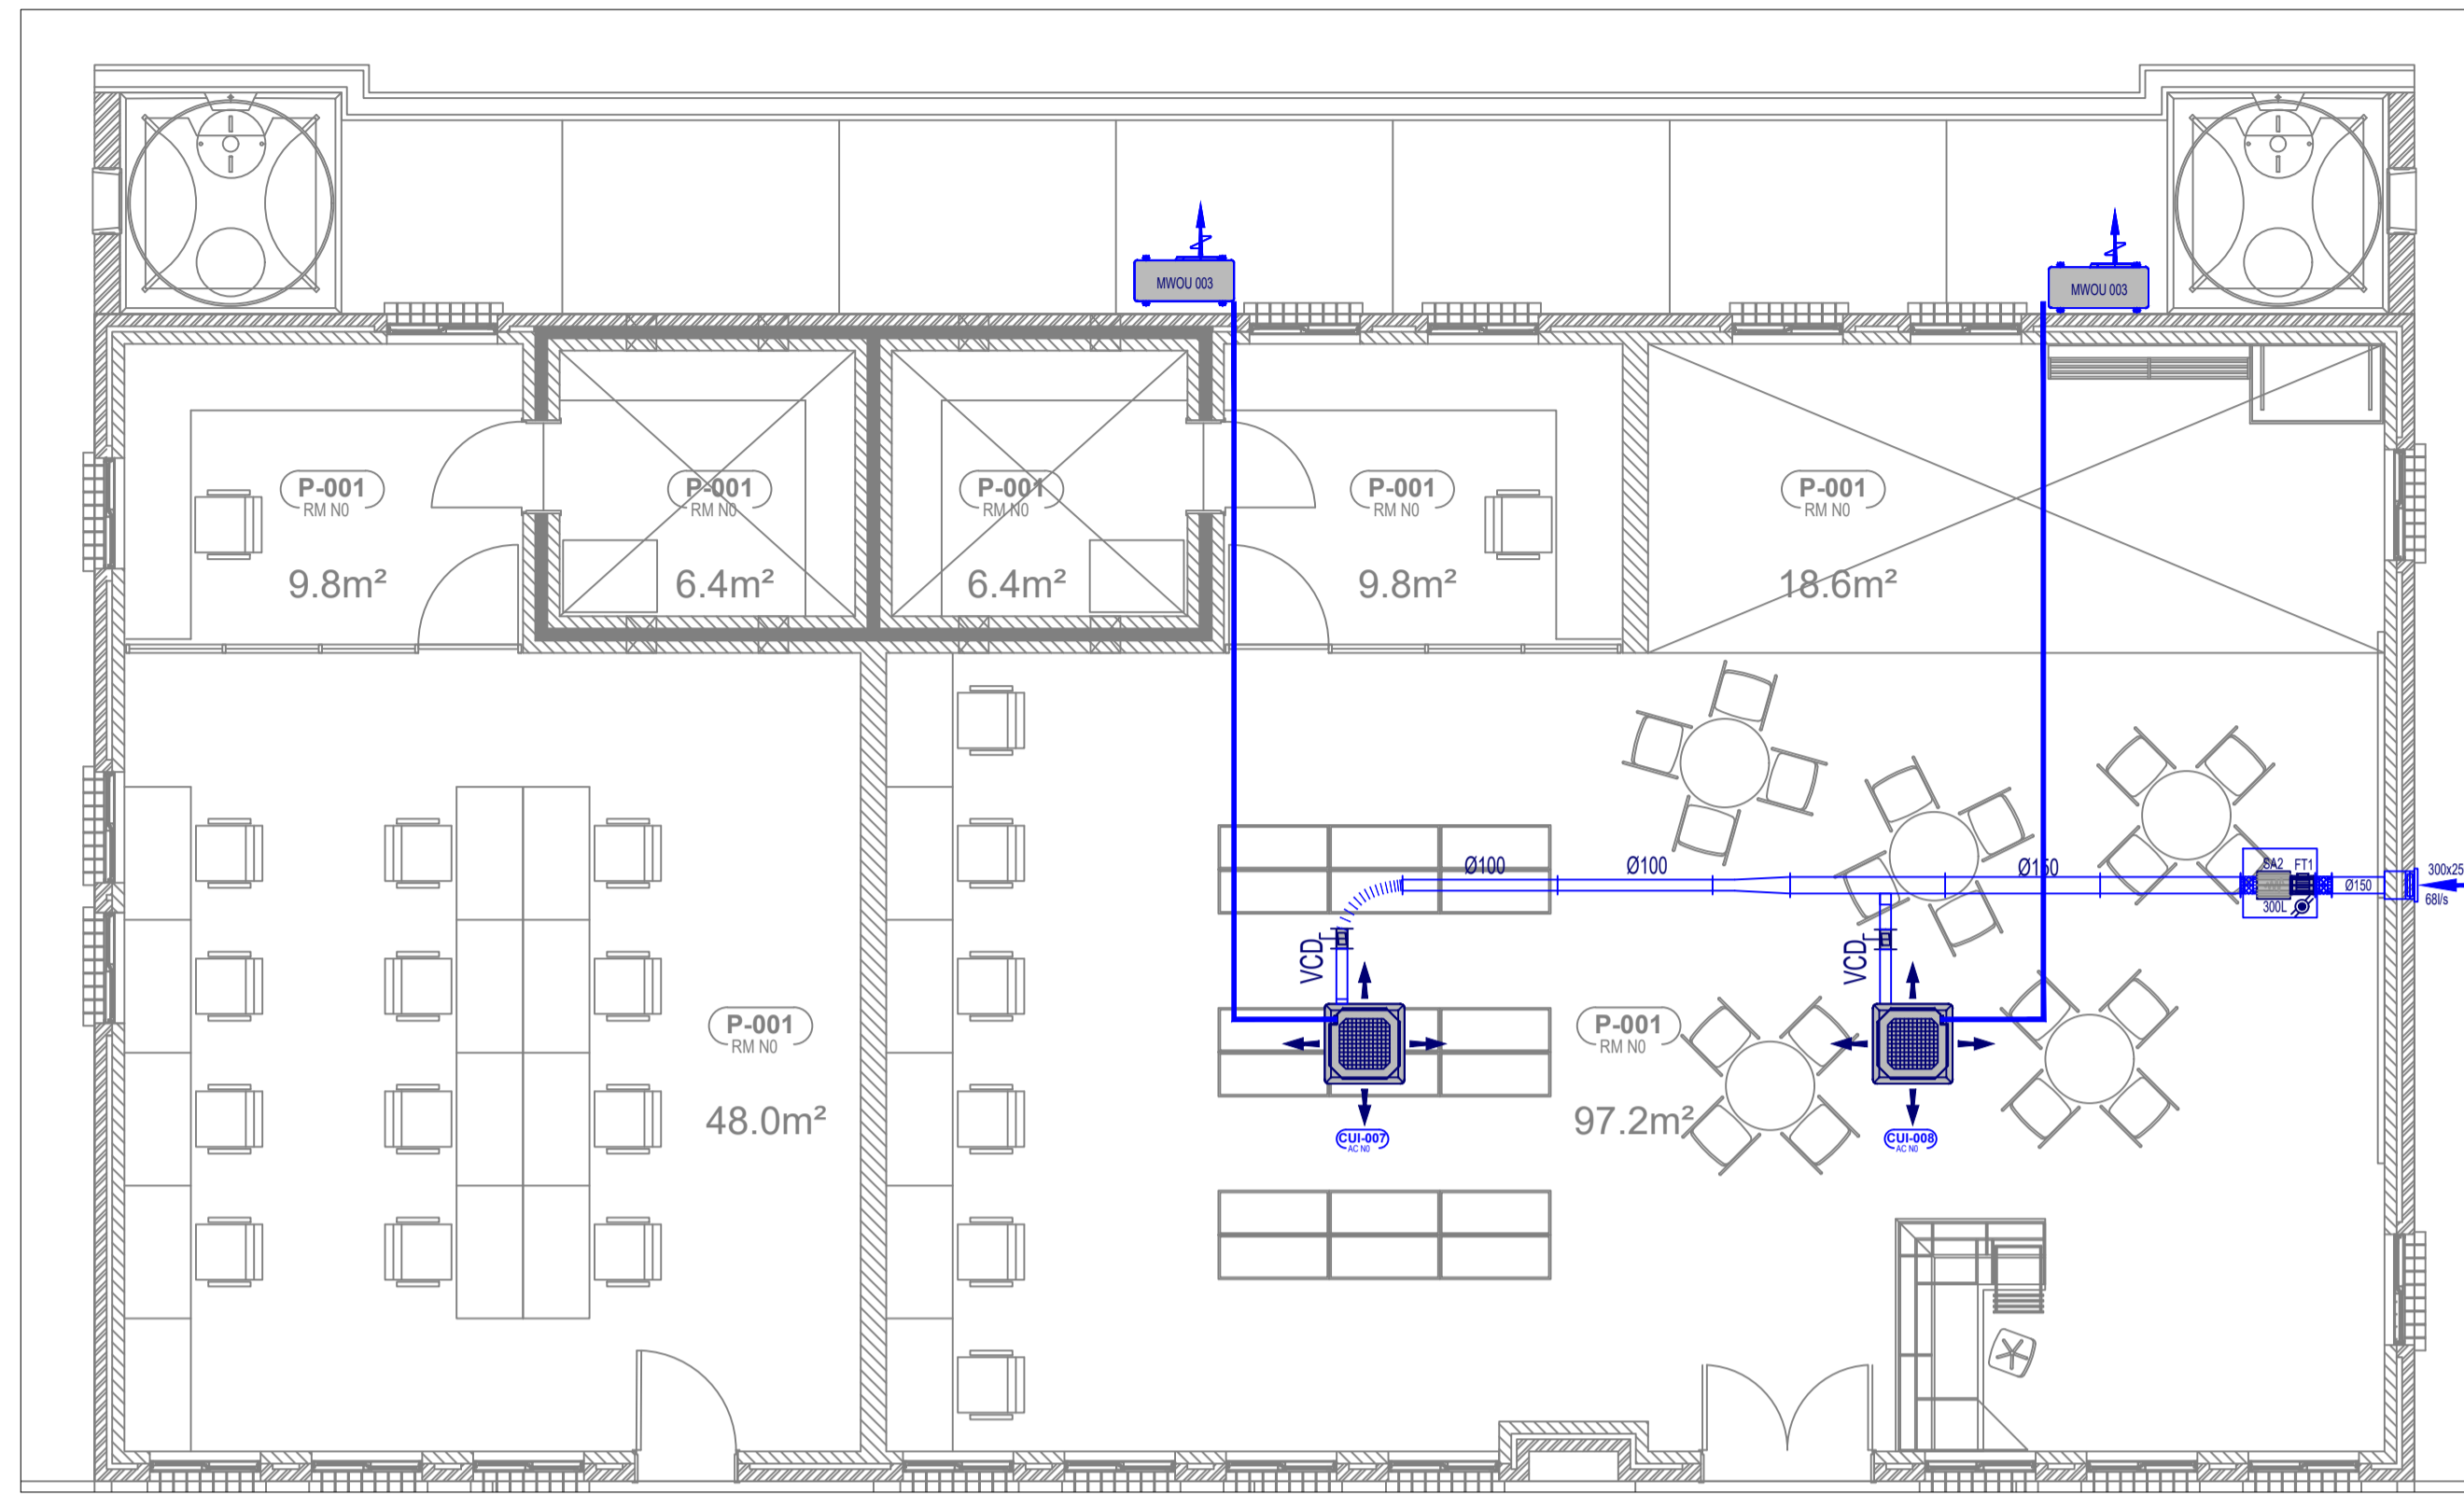

DRAWING NOTES

NOTE:
 All works to comply with and carried out in strict accordance with national building regulations SABS 5400 - 1990.
 All dimensions to be checked on site before any work is put in hand.
 This drawing must not be scaled, only figured dimensions may be used.

FAF / EAS Inline Fresh / Exhaust Air Fan

EFICE Exhaust Air Fan-Wall Mounted

GRILLE Supply / Exhaust Air Grille

WL Weather Louvre

NO.	AMENDMENT	ENG

Copyright vests in the Department of Education
 Preliminary drawings
 Certified Preliminary drawings as per Controlled Drawing
 Active Preliminary DRAWING REQUIREMENTS
 name: _____
 date: _____
 professional registration no.: _____

used file name: _____ page type: **A 1**
VENT Plans



consultant

 REG NO.: CK 300810743703
 MITHATHA OFFICE: 38 Mithatha Street, Mithatha 5100
 EAST LONDON OFFICE: 26 Rhodes Street, Durban, East London 5201
 KOKSTAD OFFICE: 13 Hawthorn Street, Kokstad 4700
 Tel: +27 47 531 1189 Fax: +27 43 531 1188
 Tel: +27 43 742 0023 Fax: +27 43 742 0023
 Tel: +27 39 727 4825 Fax: +27 39 727 1965

discipline: **MECHANICAL ENGINEER**

service: **SIVE / MALUTI SPECIAL SCHOOL PHASE-2**

WCS number: _____
 drawing title: **MALE DORMITORY- 5 HVAC LAYOUT**

ref no: **B** assigned: **Mr. M.C Mntu**
 scale: **N.T.C** drawn: **Mr. L. Maja**
 date: **April 2023** checked: **Mr. N. Kekane**

drawing number: **ME-0031-HVAC-03**

DRAWING STATUS

Description	Approved AS, BY
Issued For Concept Only	
Issued For Information Only	
Issued For Co-Ordination Only	
Issued For Preliminary Only	
Issued For Construction	
Issued For Final Construction	
AS Built Drawing	

